



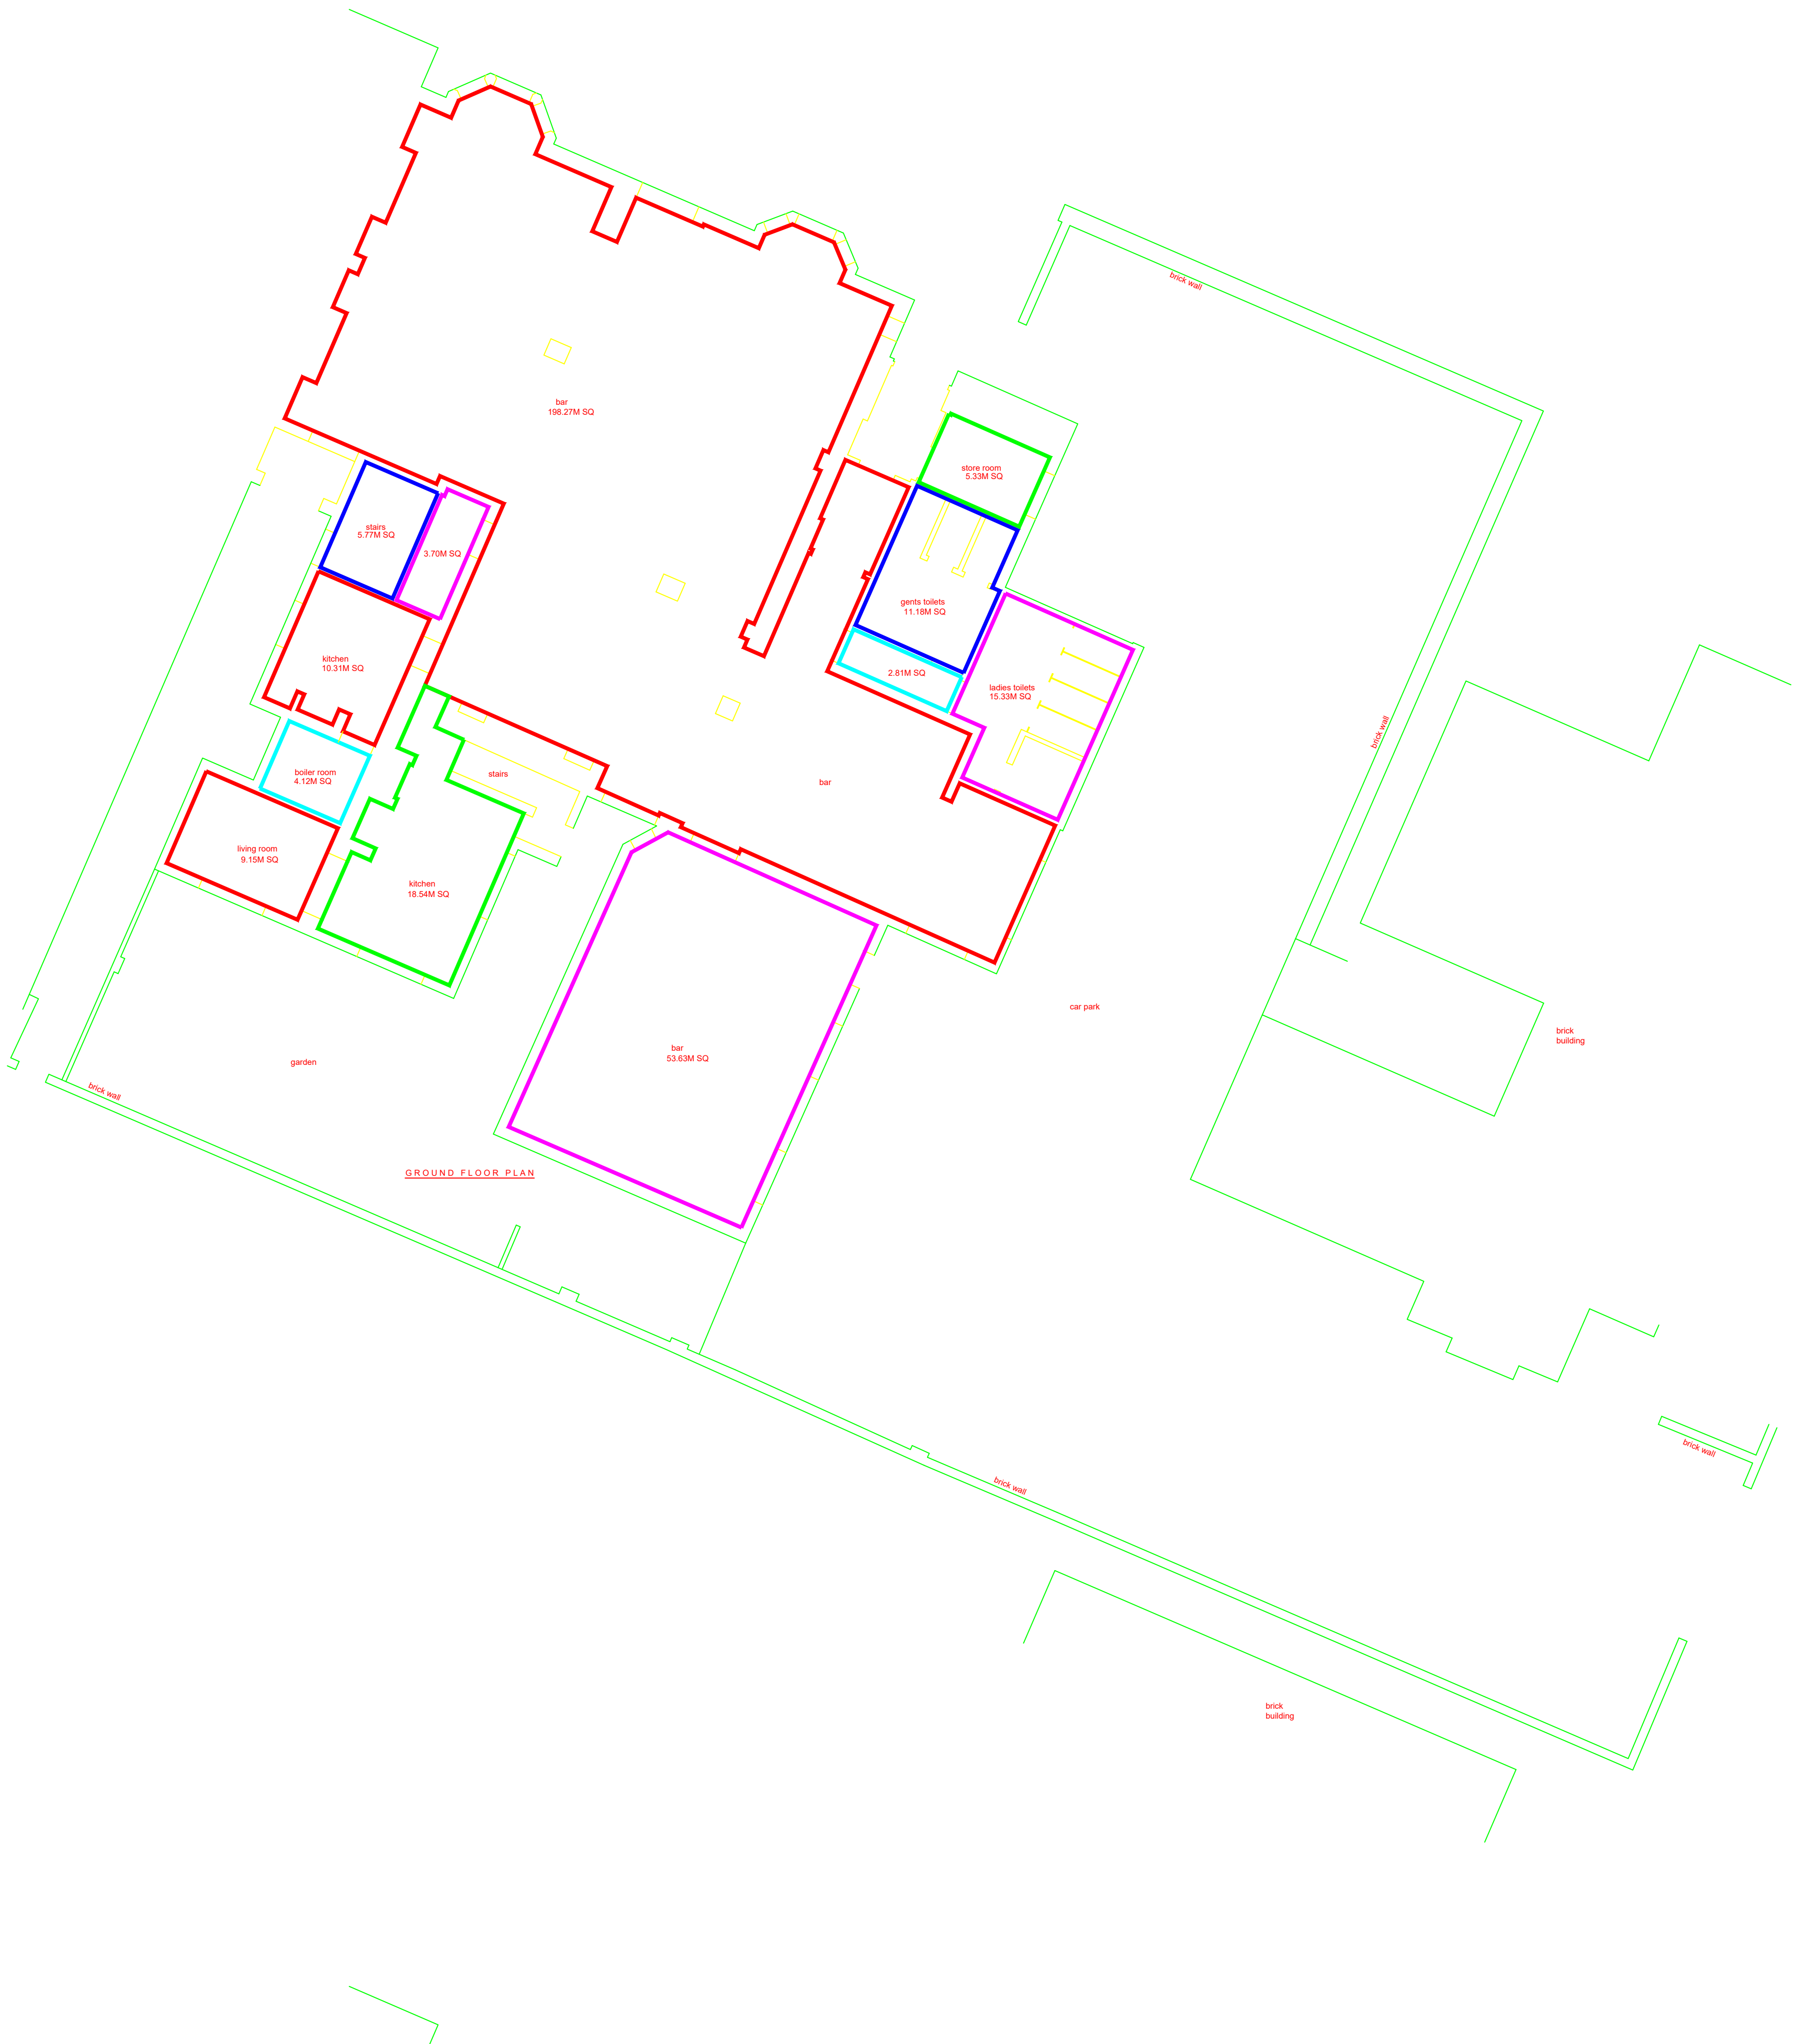

ALL LEVELS ARE IN METRES DERIVED FROM GPS TRANSFORMATION.
GRID COORDINATES ARE ORDNANCE SURVEY OSGB36 GRID DERIVED FROM GPS TRANSFORMATION. (NO SCALE FACTOR APPLIED)
PLOT SCALE ACCURACY OF 1:200.
TREE SPECIES TO BE CONFIRMED BY AN SPECIALIST IF ESSENTIAL TO THE SURVEY.
SERVICE COVERS UNDER STRUCTURES/VEHICLES OR ONES THAT ARE BURIED MAY BE OMITTED FROM THE SURVEY. PIPE DETAILS SURVEYED FROM SURFACE ONLY.
BROKEN COVERS AND COVERS WITHIN BUSY HIGHWAYS WILL NOT BE LIFTED.
OVERHEAD CABLE POSITIONS/HEIGHTS SHOULD BE TREATED AS APPROXIMATE AND ARE LIABLE TO SEASONABLE CHANGE.
COPYRIGHT AND FULL RIGHTS REMAIN WITH CRYFIELD SURVEYS LTD.

TEXT KEY -		p & r fence - post & rail fence	
av - air valve	bl - telecom	re - rodding eye	
catv - cable television	cb fence - closeboard fence	rs - road sign	
cbox - control box	cl - cover level	rw - rain water pipe	
cr - cable riser	dl - depth	sl - spot light	
ep - electric pole	el - earthing rod	sv - stop valve	
fh - fire hydrant	fl - floor level	sw - soil vent pipe	
fs - fire switch	fp - fire pole	tbl - threshold level	
g - gully	gv - gas valve	tl - top of tank	
h - height	ic - inspection cover	u/s - underside	
il - invert level	ip - lamp post	ul - unable to lift	
mh - manhole	mr - marker	vp - vent pipe	
		w/c - water filled chamber	
		wm - water meter	
		wo - wash out	
		wp - waste pipe	

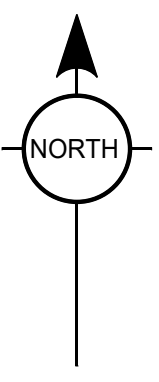

STATION SCHEDULE				
ID	EASTINGS	NORTHINGS	LEVEL	TYPE
PROJECT				
FLANNELLY'S, 59-61 HOLYHEAD ROAD, COVENTRY				
DRAWING TITLE				
GROUND FLOOR PLAN				
CLIENT				
FLANNELLY'S				
SURVEY DATE	SHEET SIZE	SURVEYOR	CHECKED	
NOV/23	A1	SJF	PDS	
DRAWING NUMBER		SCALE		
1434-02		1:100		